



Notes

1. This drawing has been prepared in accordance with the scope of RPS's appointment with its client and is subject to the terms and conditions of that appointment. RPS accepts no liability for any use of this document other than by its client and only for the purposes for which it was prepared and provided.
2. If received electronically it is the recipient's responsibility to print to correct scale. Only written dimensions should be used.
3. This drawing should be read in conjunction with all other relevant drawings and specifications.

LEGEND

- EX1 1X15W LED ROAD LANTERN POST TOP MOUNTED ON 6M COLUMN COLUMNS TO BE HEAVY DUTY WHERE CCTV CAMERAS ARE MOUNTED LUMINAIRE DETAILS AS PER LUMINAIRE SCHEDULE
- EX2 1X29W LED ROAD LANTERN POST TOP MOUNTED ON 6M COLUMN COLUMNS TO BE HEAVY DUTY WHERE CCTV CAMERAS ARE MOUNTED LUMINAIRE DETAILS AS PER LUMINAIRE SCHEDULE
- EX3 1X35W LED FLOODLIGHT POST TOP MOUNTED ON 6M COLUMN COLUMNS TO BE HEAVY DUTY WHERE CCTV CAMERAS ARE MOUNTED LUMINAIRE DETAILS AS PER LUMINAIRE SCHEDULE
- EX4 1X23W LED WALL MOUNTED FLOODLIGHT LUMINAIRE DETAILS AS PER LUMINAIRE SCHEDULE
- EX5 1X69W LED WALL MOUNTED FLOODLIGHT LUMINAIRE DETAILS AS PER LUMINAIRE SCHEDULE
- AL1 CEILING MOUNTED 4x54W T5 FLUORESCENT LUMINAIRE DETAILS AS PER LUMINAIRE SCHEDULE
- AE AS ABOVE INCORPORATING EMERGENCY LIGHTING
- DB DISTRIBUTION BOARD
- ME ONE WAY LIGHT SWITCH INDICATES NO. OF GANG

RECEIVED BY THE
 PLANNING DEPARTMENT
 28 SEP 2015
 P-15-077

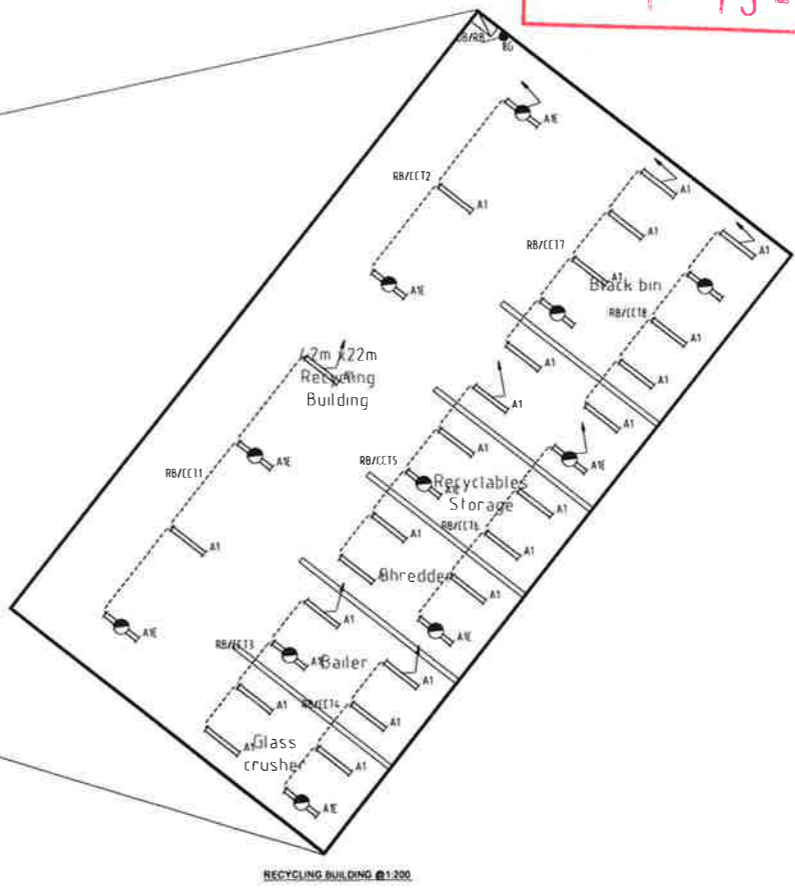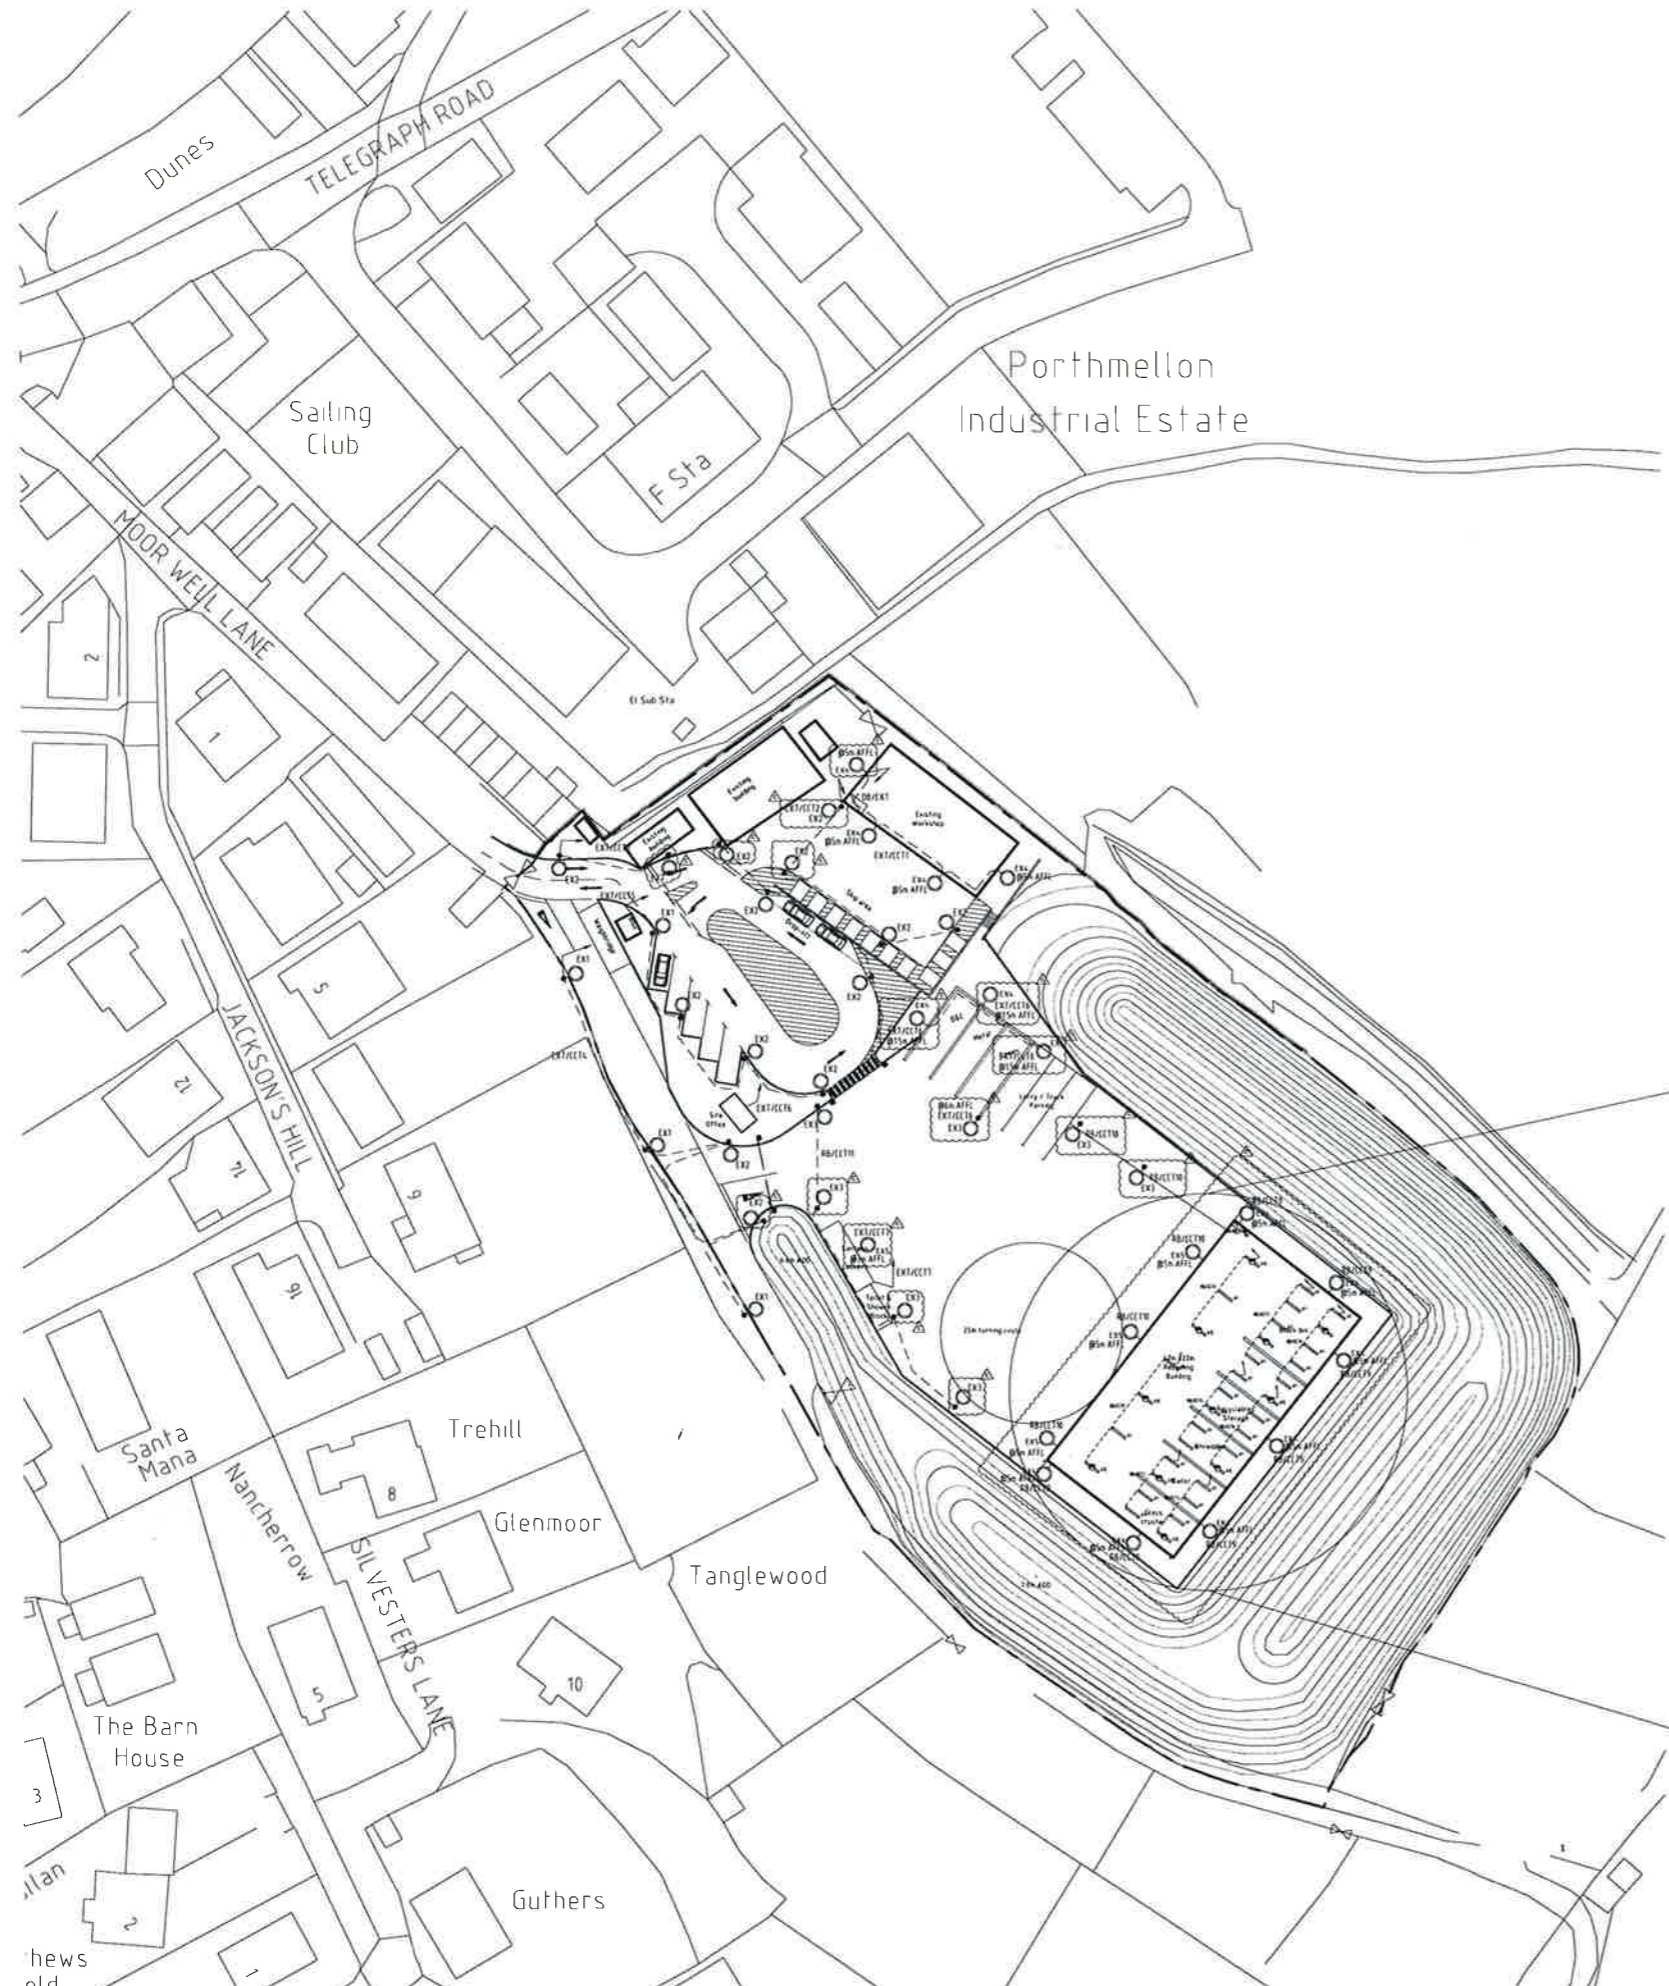

C	Revised lighting layout to suit latest civil engineer's engineering layout JKK8520-06 Rev A	BT	JRS	16.06.15
B	Lighting Layout for Workshop Store and Recycling Building and Circuit References Added	BT	JRS	16.01.15
A	Preliminary Issue	BT	JRS	19.12.14
Rev	Description	By	Ckd	Date



Noble House,
Capital Drive, Lindford Wood, Milton Keynes MK14 6QP
T: +44 (0)1908 658638 E: rps@rpsgroup.com F: +44 (0)1908 658639

Client Council of the ISLES OF SCILLY

Project Porthmellon Waste Management Facility, St. Mary's, Isles of Scilly

Title Site E: Internal Lighting Layout

Status	Scale	Date Created
Preliminary	1:500 @ A1	Dec 14
Project Leader	Drawn By	Checked by
JRS	BT	JRS

Drawing Number	Rev
BRM07665 XX-E-6301	C